
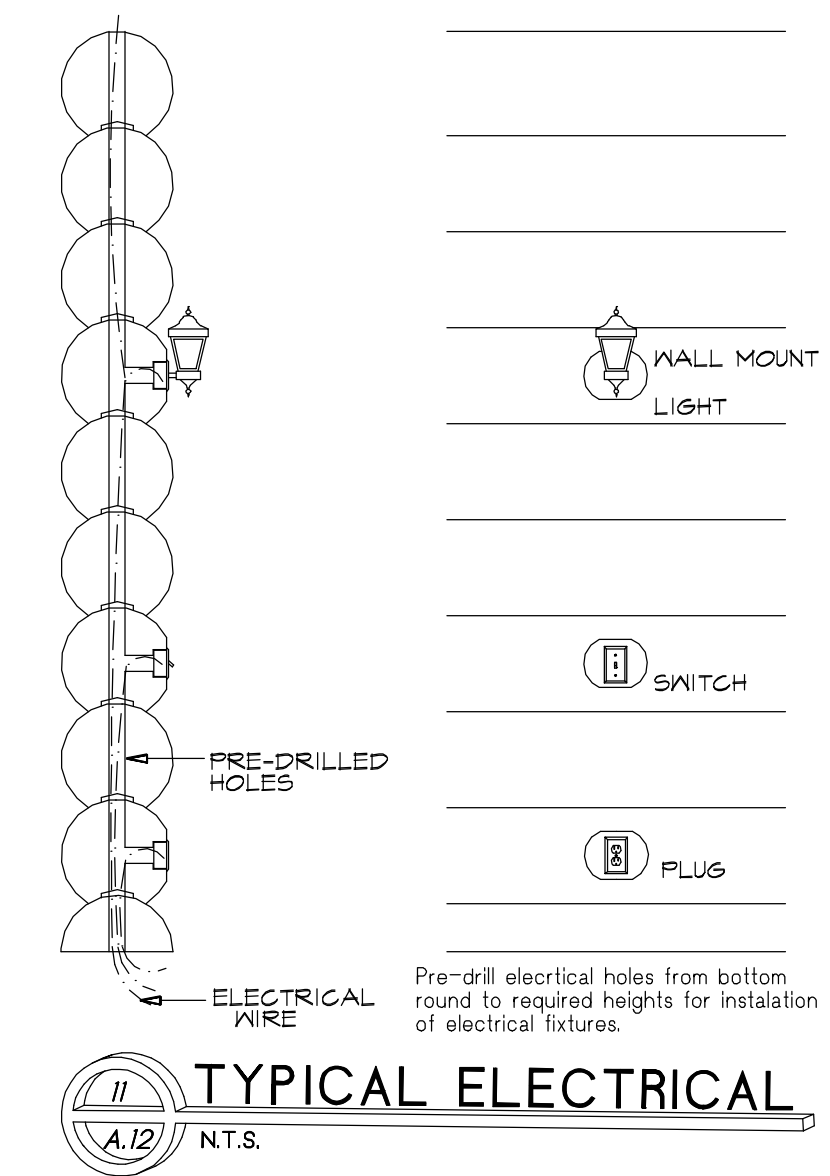
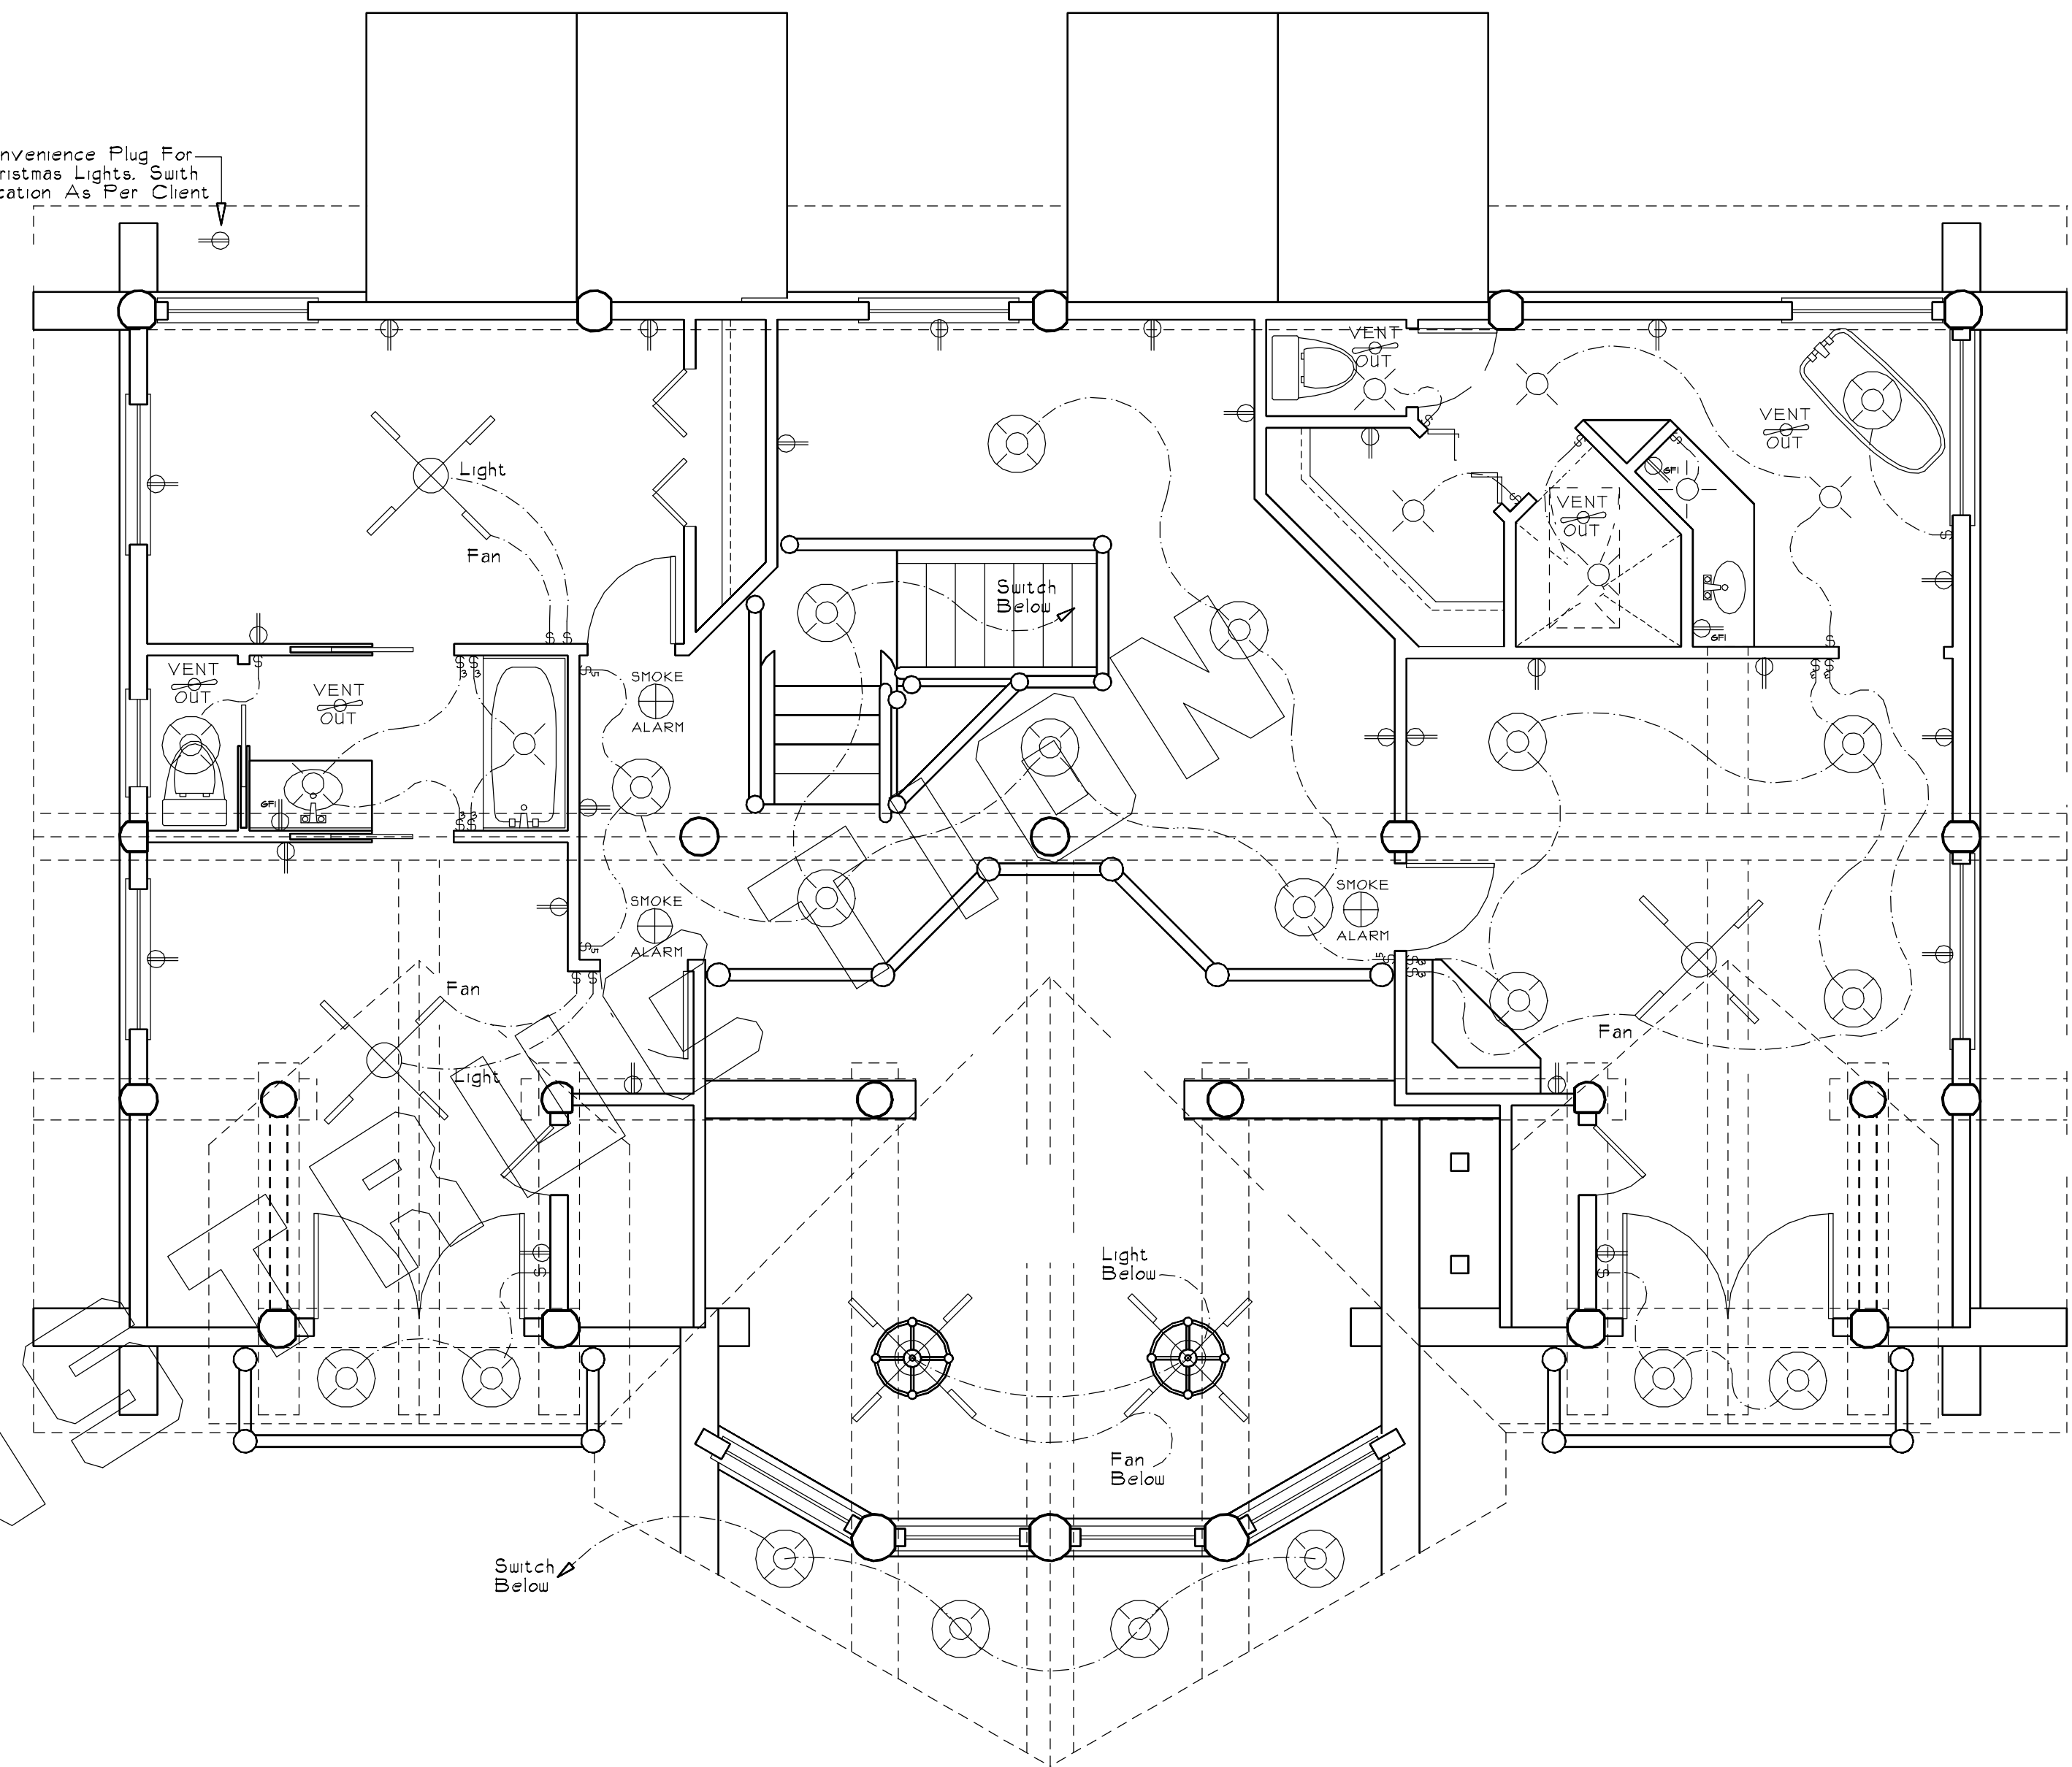


LEGEND

	CEILING LIGHT		WALL OUTLET
	POT LIGHT		WATER PROOF OUTLET
	VENTING FAN		GROUND FAULT INTERRUPT
	SMOKE ALARM		SWITCHED PLUG
	MOTION LIGHTS		WALL OUTLET 220
	CEILING FAN		FLOOR PLUG
	TRACK LIGHTING		LIGHT SWITCH
	HANGING LAMP		3 WAY LIGHT SWITCH

NOTE:
ALL RECEPTICALS ARE SHOWN AS AN ESTIMATE AND MUST BE CLARIFIED WITH CUSTOMER PRIOR TO CONSTRUCTION.

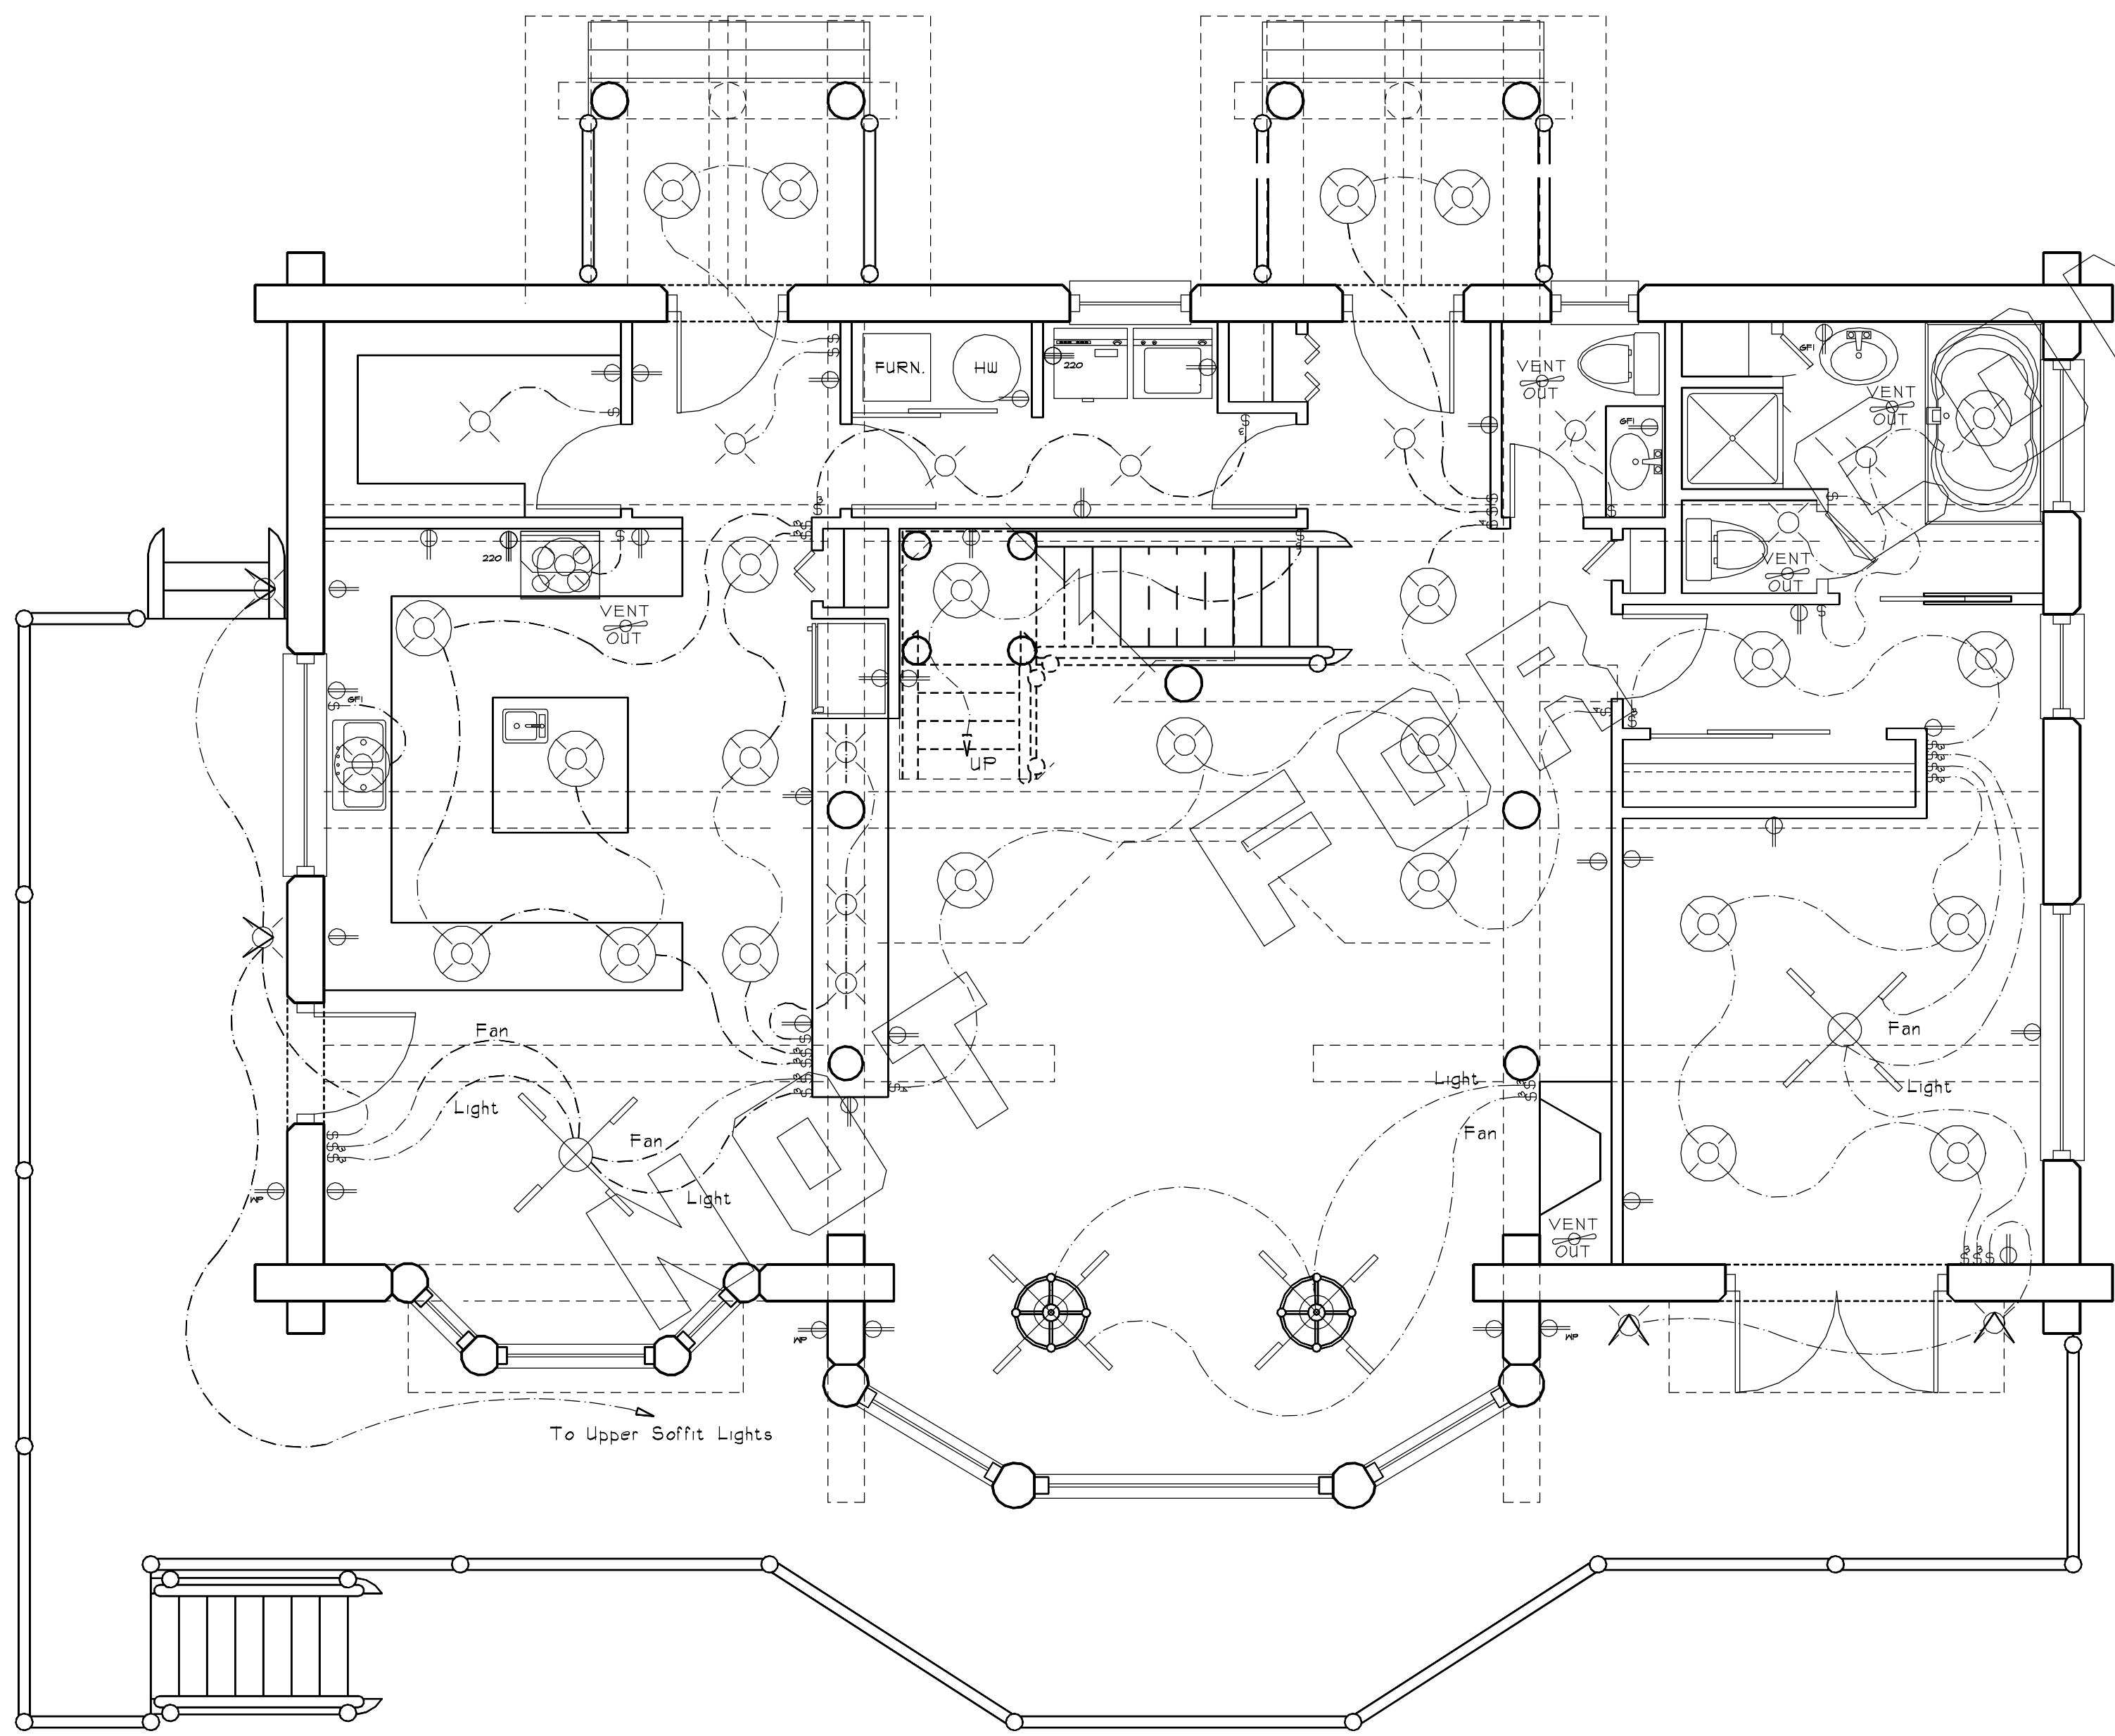

ISSUED FOR PERMIT	
REVISIONS	
1	28 FEB. 2003
2	17 JUNE 2003
3	
4	
5	

The Log Connection
107-208 Ellis St.
Penticton, BC
V2A 4L6
Phone: (250) 770-9031
Toll Free 1-888-207-0210
E-mail: logconn@thelogconnection.com
www.thelogconnection.com

The Log Connection
Log Home Design Specialist

A.12

ELECTRICAL PLAN
PAGE TITLE 1 DETAILS
SCALE AS NOTED
DATE NOV. 18 2002
DRAWN BY ROBERT WOOD
CHECKED BY

A.12