



**LEGEND**

	CEILING LIGHT		WALL OUTLET
	POT LIGHT		WATER PROOF OUTLET
	VENTING FAN		GROUND FAULT INTERRUPT
	SMOKE ALARM		SWITCHED PLUG
	MOTION LIGHTS		WALL OUTLET 220
	CEILING FAN		FLOOR PLUG
	TRACK LIGHTING		LIGHT SWITCH
	HANGING LAMP		3 WAY LIGHT SWITCH


NOTE:  
ALL RECEPTICALS ARE SHOWN AS AN ESTIMATE AND MUST BE CLARIFIED WITH CUSTOMER PRIOR TO CONSTRUCTION.

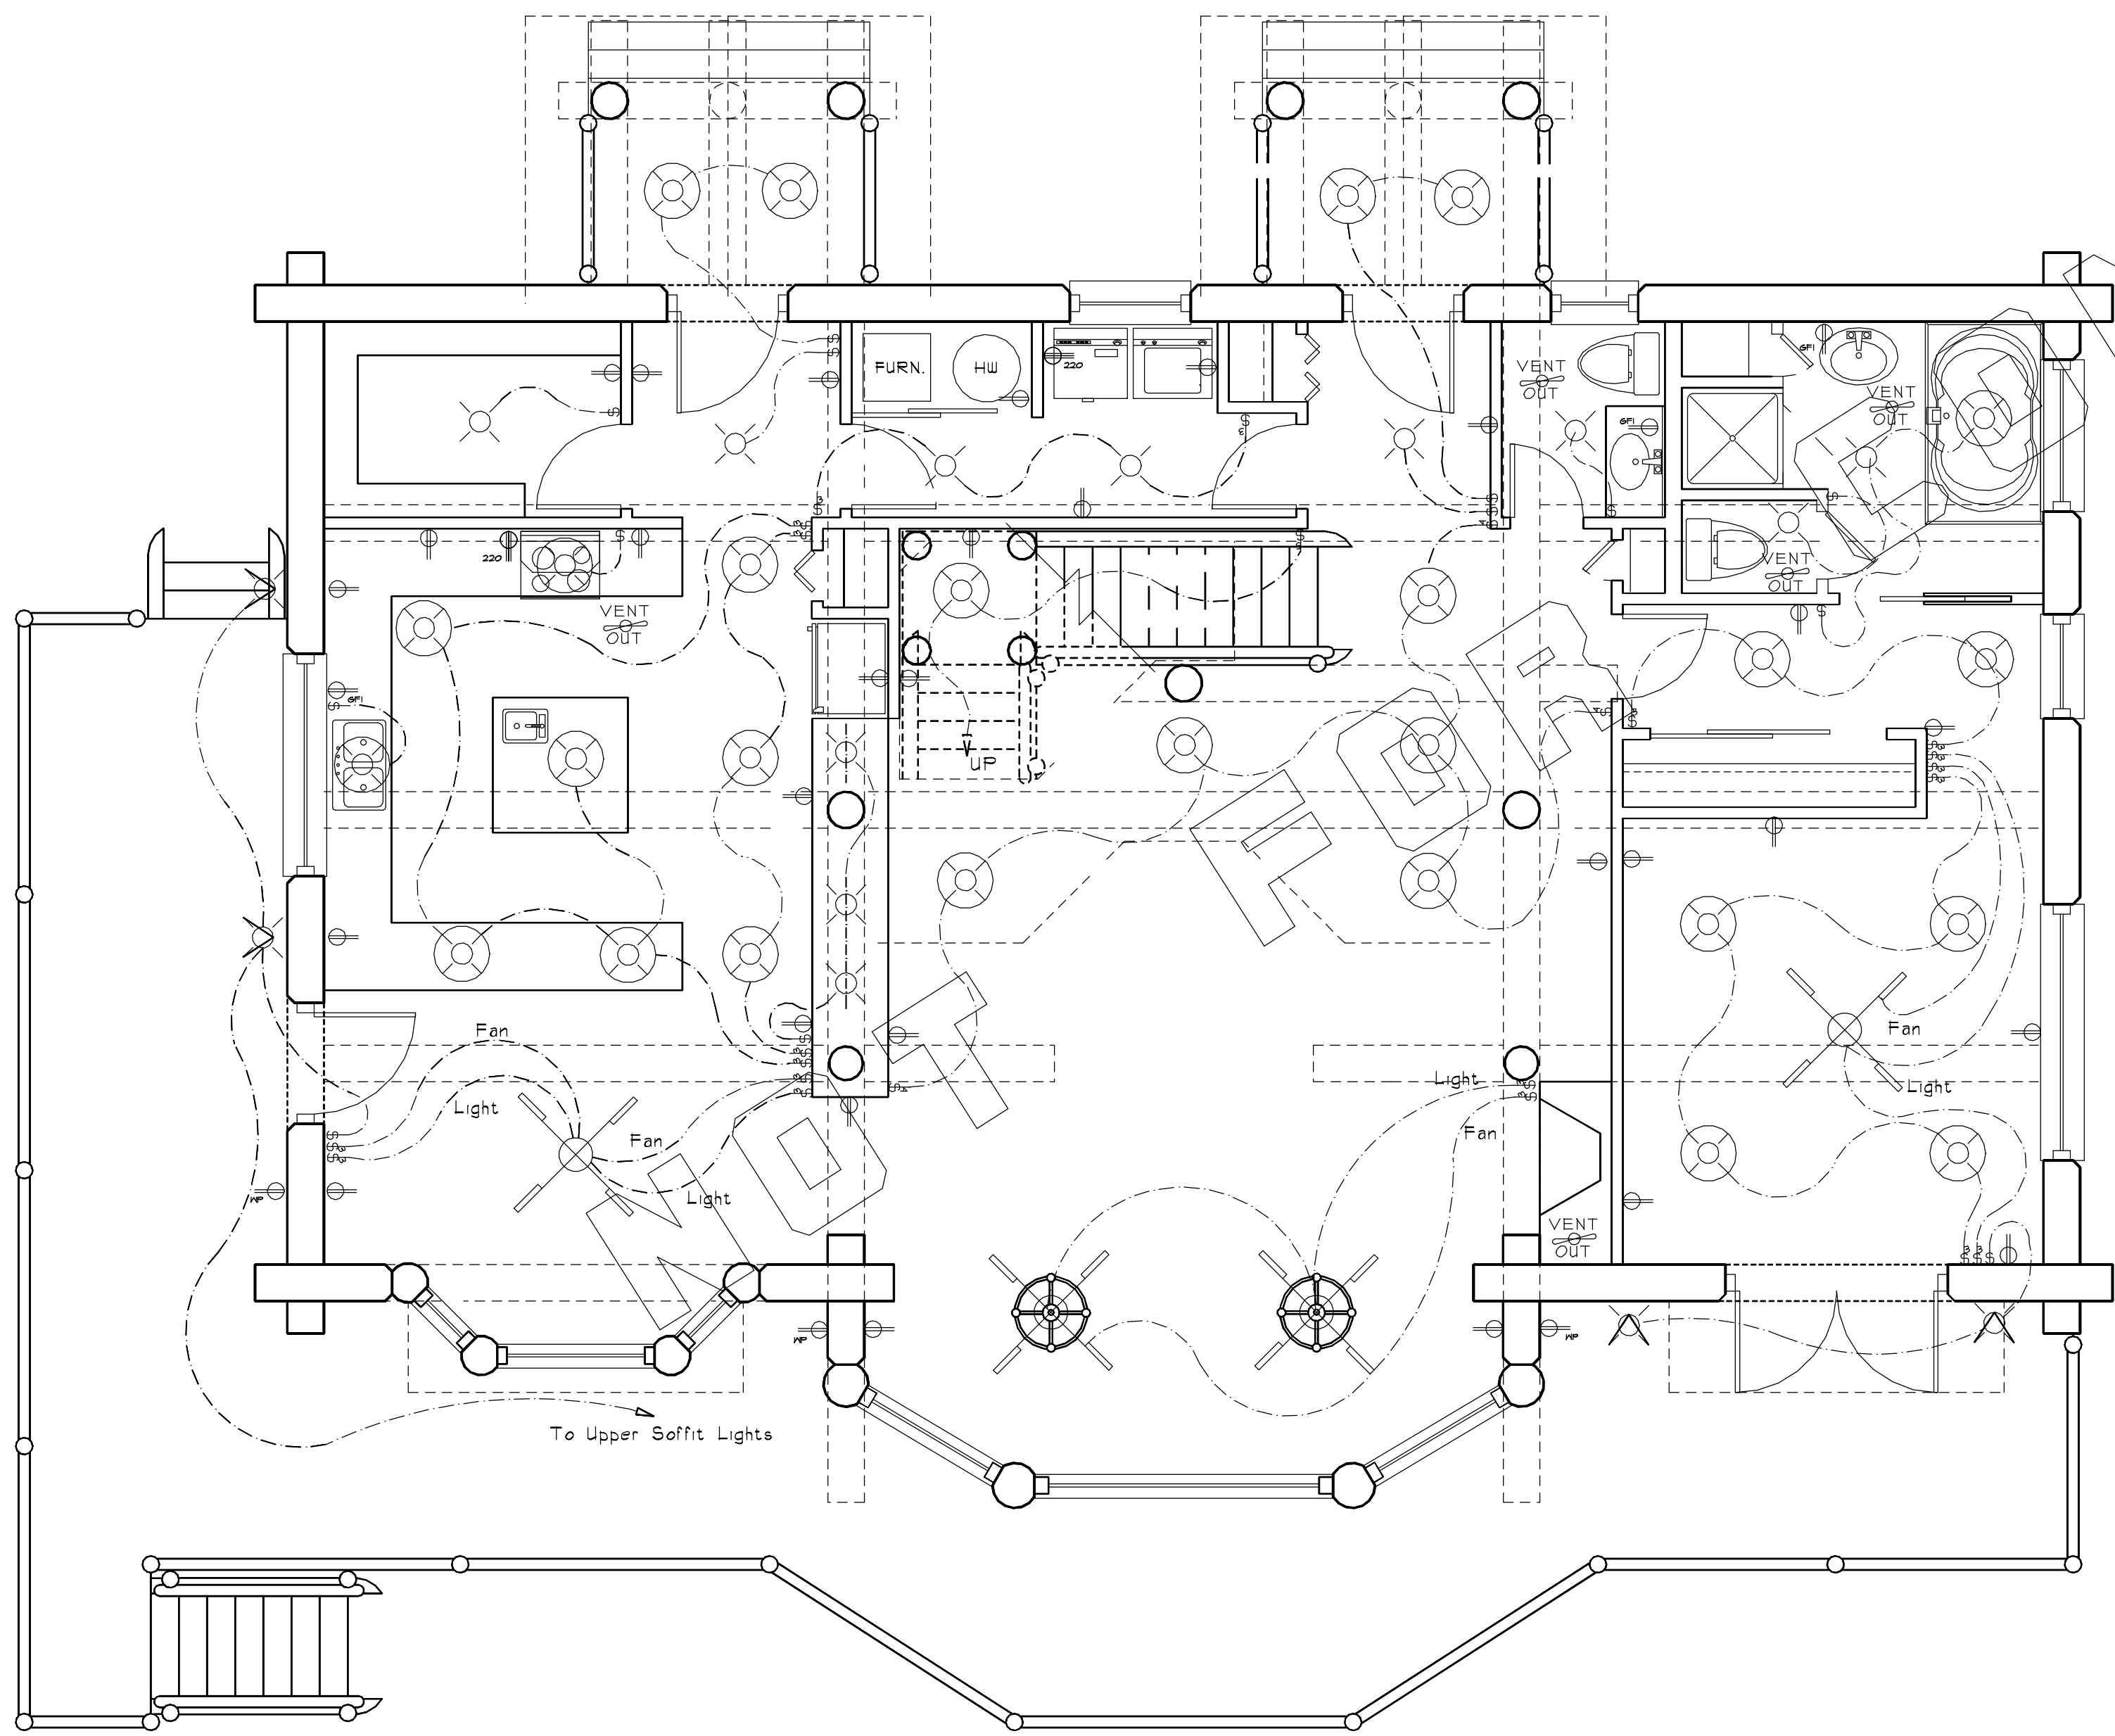

**1 MAIN FLOOR ELECTRICAL**  
A.12 N.T.S.

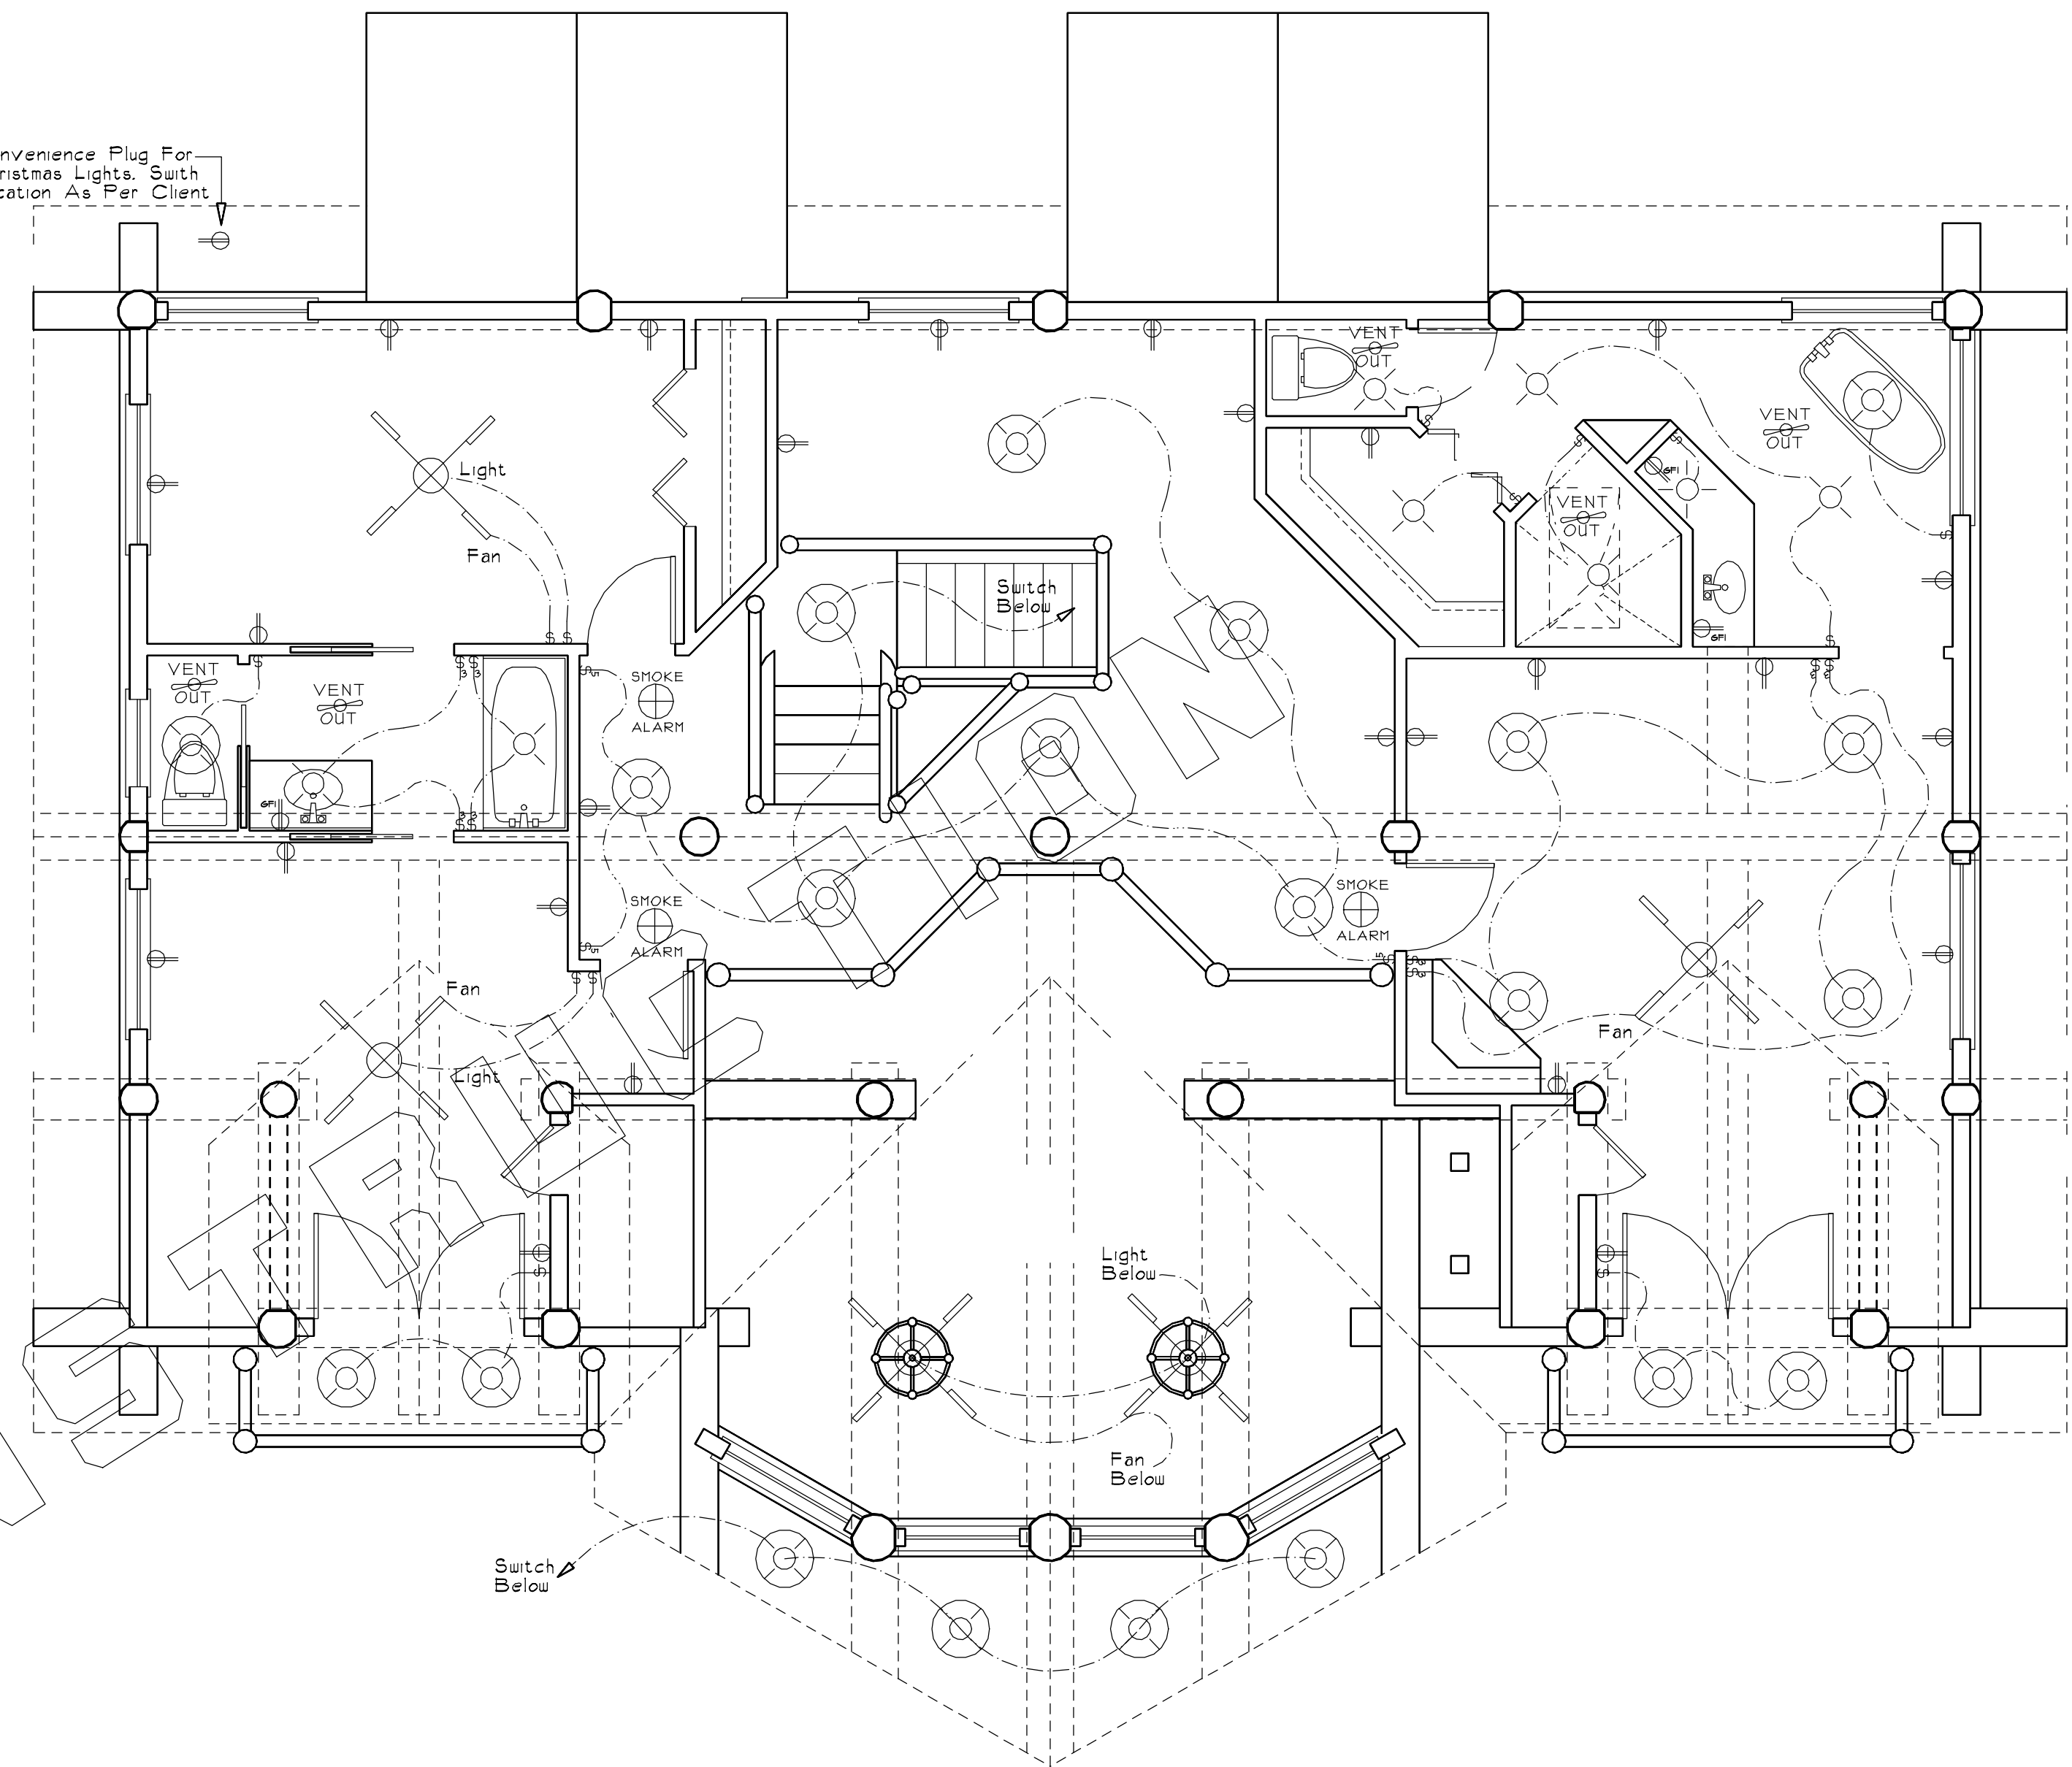

**2 UPPER FLOOR ELECTRICAL**  
A.12 N.T.S.

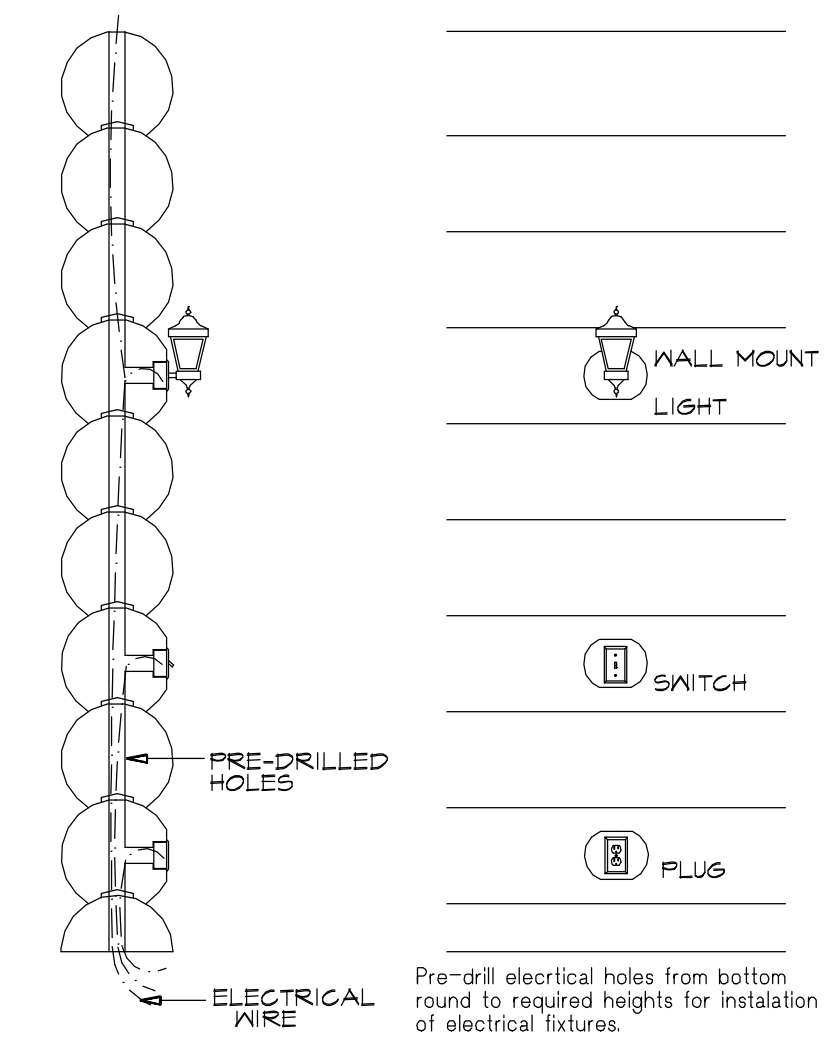

**11 TYPICAL ELECTRICAL**  
A.12 N.T.S.

ISSUED FOR PERMIT	
REVISIONS	
1	28 FEB. 2003
2	17 JUNE 2003
3	
4	
5	

The Log Connection  
101-208 Ellis St.  
Penticton, BC  
V2A 4L6  
Phone: (250) 770-9031  
Toll Free 1-888-207-0210  
E-mail: log@thelogconnection.com  
www.thelogconnection.com

**The Log Connection**  
Log Home Design Specialist

A.12

**ELECTRICAL PLAN**  
PAGE TITLE 1 DETAILS  
SCALE AS NOTED  
DATE NOV. 18 2002  
DRAWN BY ROBERT WOOD  
CHECKED BY

A.12